


ELECTRICAL TEST:
1.PASS 8K@120Hz TEST

LENGTH(mm)	LENGTH(mm)
5000±50	40000±100
10000±100	50000±100
15000±100	60000±100
20000±100	70000±100
25000±100	80000±100
30000±100	90000±100
	100000±100

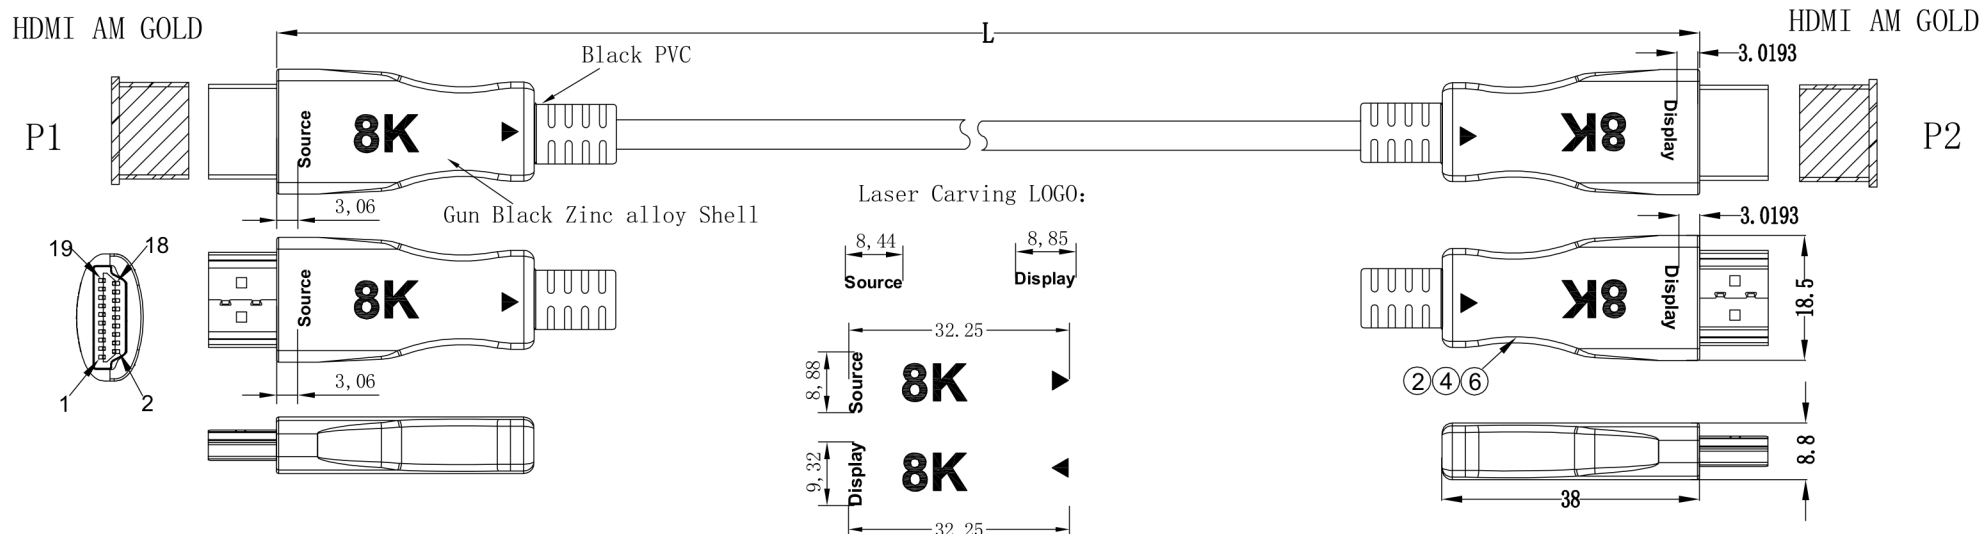

PIN ASSIGNMENT

CN 1		CN 2
3	FIBER-1	3 TMS data2-
1		1 TMS data2+
2		2 TMS data2 Shield
6	FIBER-2	6 TMS data1-
4		4 TMS data1+
5		5 TMS data1 Shield
9	FIBER-3	9 TMS data0-
7		7 TMS data0+
8		8 TMS data0 Shield
12	FIBER-4	12 TMS Clock-
10		10 TMS Clock+
11		11 TMS Clock Shield
13		13 CEC
14		14 Utility (N.A)
15		15 SCL
16		16 SDA
17		17 DDC/CEC Ground
18		18 +5V Power
19		19 Hot Plug Detect
SHELL		SHELL

(4C Optical fiber)+(1/0.32BC*1P+AL-Foil)*1C+1/0.20BC*2C+1/0.254BC*2C+7/0.20TC*1C
+FILL+D7/0.12TC+AL-Foil BLACK PVC OD:4.5±0.15mm

				DESCRIPTION	FINISHED PRODUCT'S FIGURE	SCALE	FIT	UNITS: MM	1RD ANGLE
				MODEL NO.		△			
APPROVED	CHECKED	DRAWING	DESIGNED	DRAWING NO.	256-***	△			
		WRX	WRX	FINISHING		△	2022/03/12		A1
				MATERIAL		SYM	DATE		REVISION